
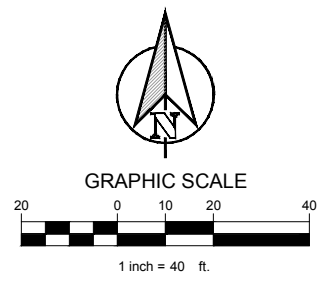


PLOTTED BY: CLAY CRISTY  
 PLOT DATE: 1/10/2023 9:02 AM  
 LOCATION: Z:\PROJECTS\2022-201 KROGER KELLER FUEL 537\CADD\EXHIBIT\KROGER KELLER FUEL CSP 6.DWG  
 LAST SAVED: 1/10/2023 9:01 AM

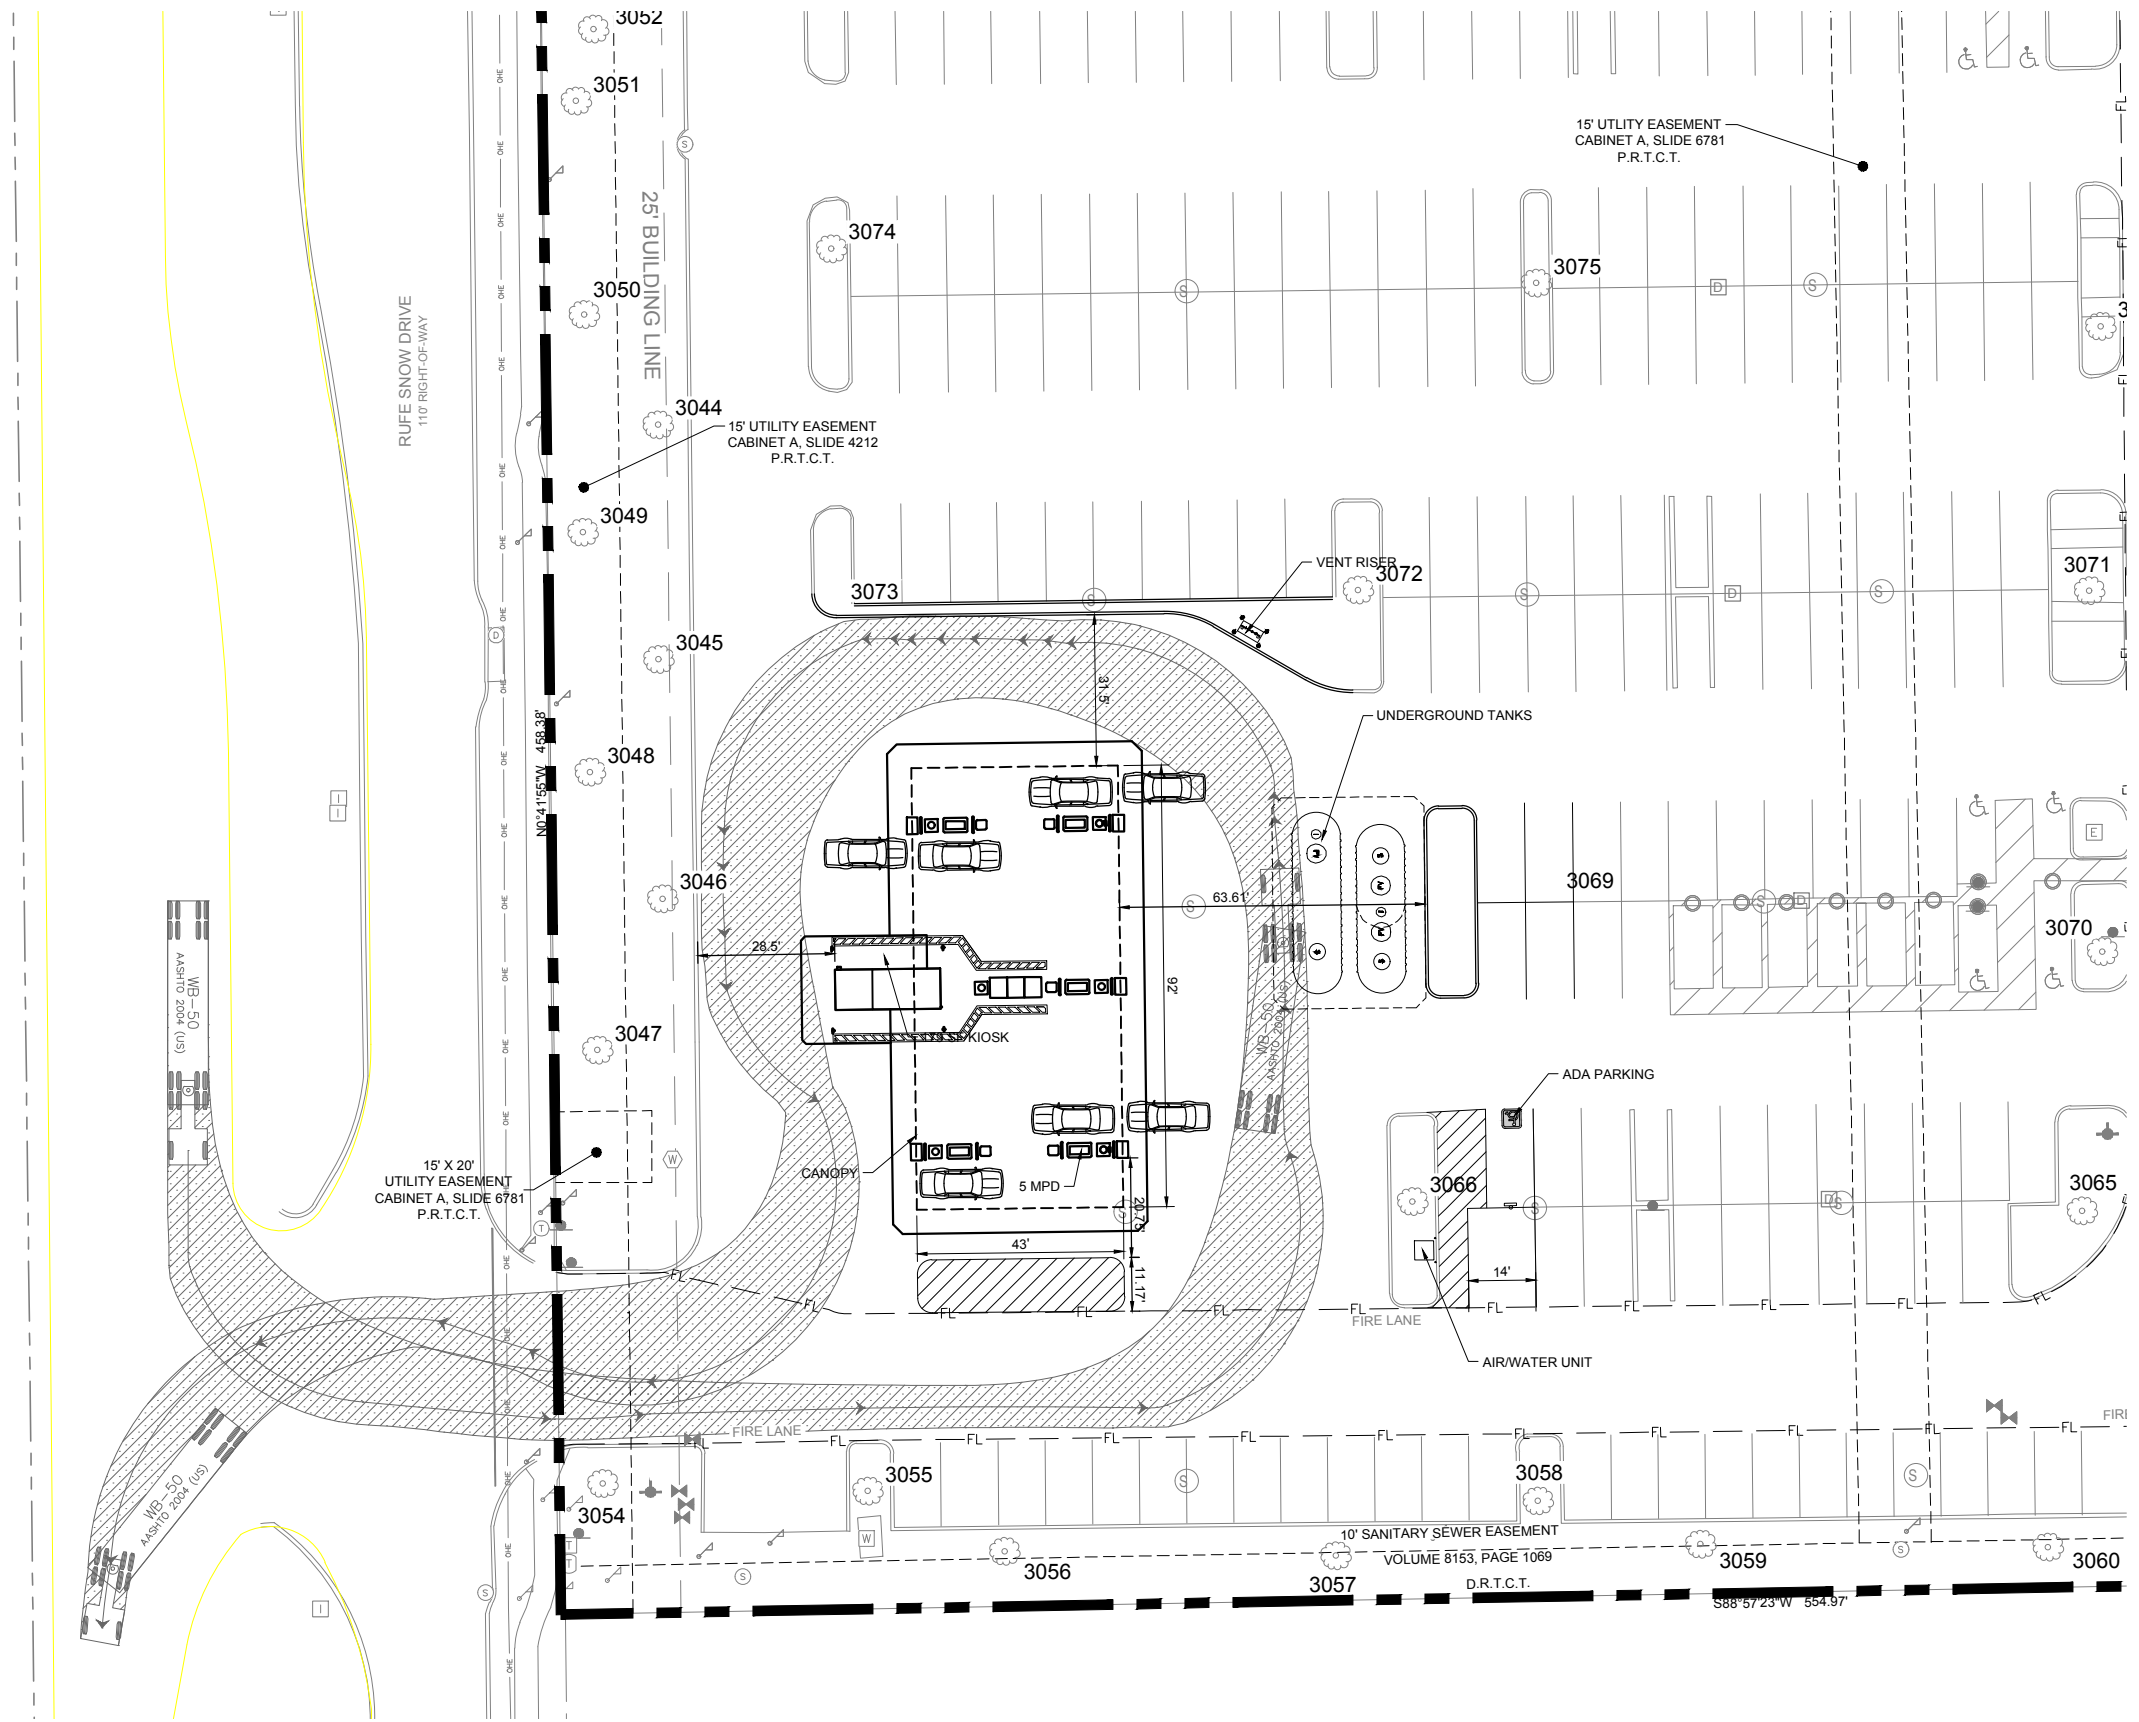

TEXAS REGISTRATION #14199  
**CLAYMOORE ENGINEERING**  
 1903 CENTRAL DR. SUITE #1  
 BOZARD, TX 75822  
 PHONE: 817.281.0272  
 WWW.CLAYMOORE.COM

**PRELIMINARY**  
 FOR REVIEW ONLY  
 Not for construction purposes.  
**CLAYMOORE ENGINEERING**  
 ENGINEERING AND PLANNING CONSULTANTS  
 Engineer: CLAY CRISTY  
 P.E. No. 109800, Date: 1/10/2023

**KROGER - 537  
 FUEL CENTER  
 KELLER, TEXAS**

No.	DATE	REVISION	BY

**SITE PLAN**

DESIGN:	CLC
DRAWN:	HV/JV
CHECKED:	CLC
DATE:	1/10/2023
SHEET	
<b>CSP-6</b>	
File No.	